



City of Chicago



Or2020-295

Office of the City Clerk

Document Tracking Sheet

Meeting Date:	11/16/2020
Sponsor(s):	Cardona, Jr. (31)
Type:	Order
Title:	Issuance of permits for sign(s)/signboard(s) at 4441 W Diversey Ave - west elevation
Committee(s) Assignment:	Committee on Zoning, Landmarks and Building Standards

CITY COUNCIL
COMMITTEE ON ZONING, LANDMARKS AND BUILDING STANDARDS

COUNCIL ORDER

RE: Approval of sign over 100 square feet in area or over 24 feet above grade

ORDERED, that the City Council hereby approves the following sign application submitted by:

Applicant*: Dollar Tree

(* The Applicant is the owner of the real property or the business tenant of the real property. Do not list the sign contractor, sign erector, sign company or advertising entity in the above space.)

This Order approves the following sign in accordance with Municipal Code of Chicago Section 13-20-680:

Address of Sign: 4441 W Diversey Ave Chicago, IL 606

Zoning District: C1-1

DOB Sign Permit Application #: 100248714

Sign Details:

1. On-premise X OR Off-premise _____

2. Static sign X OR Dynamic-image display sign _____

3. Number of sign faces 2

4. Projecting over the public way Yes (Yes or No) If yes, Public Way Use #: 1123048

5. Dimensions: Length 3 feet 10 inches Height 15 feet 4 inches

Total square feet in area: 58 feet 9 inches

6. Height above grade: 24 feet _____ inches


7. Elevation (side of building or lot where the sign will be erected): West

8. Name of Sign Contractor/Erector: Jones Sign Co Inc

To be legal, such sign shall comply with all provisions of Title 17 of the Chicago Municipal Code ("Zoning Ordinance") and all other provisions of the Municipal Code governing the permitting, construction and maintenance and removal of signs and sign structures. Failure of the applicant and the applicant's successors to comply shall be grounds for invalidation or revocation of the sign permit.

[Signature]
Alderman

3185
Ward

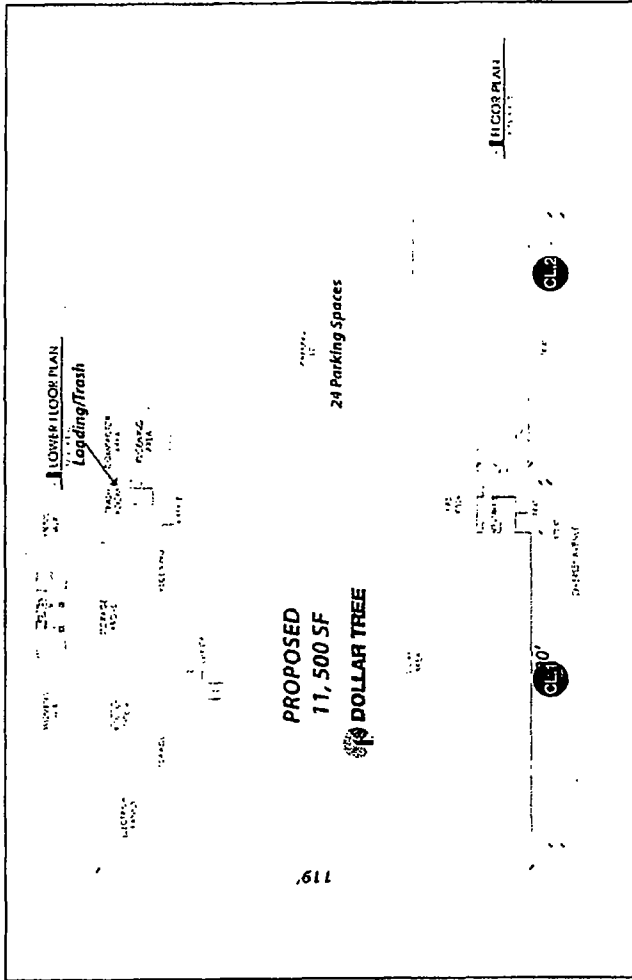


WORK SCOPE

CL1 36" CHANNEL LETTERS / 42" LOGO

CL2 14 3/8" CHANNEL LETTERS ON EXISTING SIGN

JONES SIGN Your Vision Accomplished GREEN BAY · PHILADELPHIA SAN DIEGO · LAS VEGAS www.jonesign.com	JOB # 213643-R3 DATE 2/16/2016 DESIGNED BY JIM CHECKED BY JIM DATE 2/16/2016	CLIENT APPROVAL UNANIMOUS APPROVAL QC	DATE DATE QC APPROVED QC	DOLLAR TREE	EXTERIOR SIGNAGE 4441 W. Diversey Chicago, IL 60639	SHEET NUMBER 0.0
	CONCEPTUAL					

NOT TO SCALE. THIS DRAWING IS A CONCEPTUAL REPRESENTATION OF THE PROPOSED SIGNAGE. IT IS NOT A CONTRACT DOCUMENT. THE FINAL DESIGN AND CONSTRUCTION SHALL BE DETERMINED BY THE CLIENT AND THE SIGNAGE MANUFACTURER. THE CLIENT SHALL BE RESPONSIBLE FOR OBTAINING ALL NECESSARY PERMITS AND APPROVALS FROM THE LOCAL AUTHORITIES. THE SIGNAGE MANUFACTURER SHALL BE RESPONSIBLE FOR THE FABRICATION AND INSTALLATION OF THE SIGNAGE. THE CLIENT SHALL BE RESPONSIBLE FOR THE MAINTENANCE AND REPAIR OF THE SIGNAGE. THE SIGNAGE MANUFACTURER SHALL BE RESPONSIBLE FOR THE REMOVAL OF THE SIGNAGE IF SO REQUESTED BY THE CLIENT.

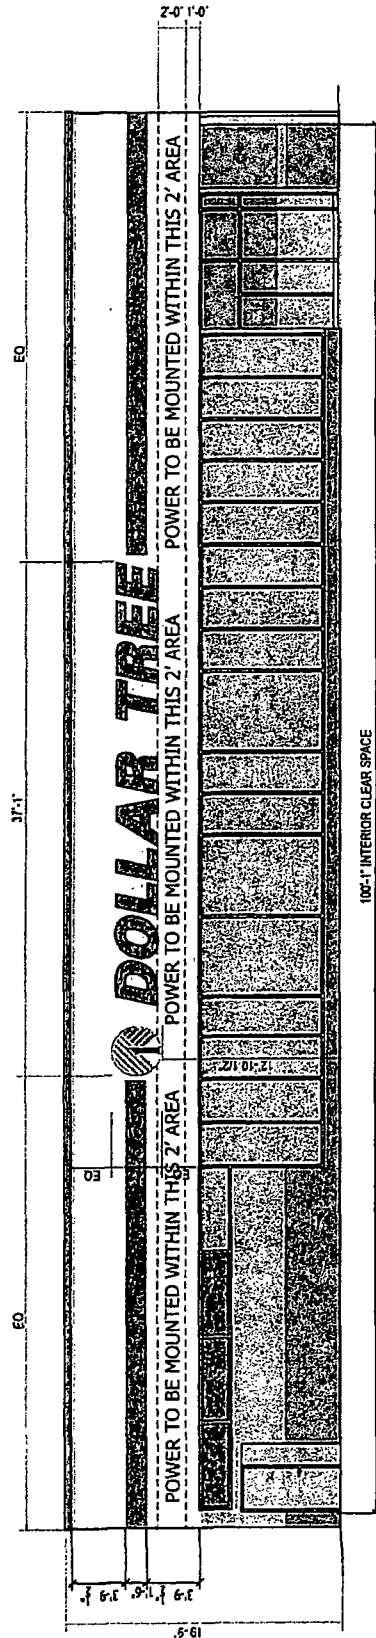

SCALE: 1/8"=1'

PROPOSED ELEVATION

- SW ENVY
- SW BALANCED BEIGE / STO SANDSTONE
- SW AESTHETIC WHITE / STO SMOKED PUTTY
- SW VIRTUAL TAUPE

JONES SIGN Your Vision Accomplished GREEN BAY • PHILADELPHIA SAN DIEGO • LAS VEGAS www.jonesign.com	J05 # 213643-R3 DATE 2/16/2016 DESIGNED BY JMI DRAWN BY JMI CHECKED BY JMI APPROVED BY JMI	CLIENT APPROVAL LABORIZED APPROVAL OC APPROVED	DATE DATE DATE	EXTERIOR SIGNAGE 4441 W. Diversey Chicago, IL 60639 1575-1575-1575 CONCEPTUAL	SHEET NUMBER 0.1
	1575-1575-1575 CONCEPTUAL				


CL.1 36" FACE LIT CHANNEL LETTERS / 42" LOGO (Qty 1)

SQUARE FOOTAGE: 129.79
 ALLOWABLE SQUARE FOOTAGE: 400
 DISTANCE FROM BACK OF SIGN TO CURB: 17'
 DISTANCE FROM FRONT OF SIGN TO CURB: 11'-2"




EXISTING ELEVATION

SCALE: N.T.S.

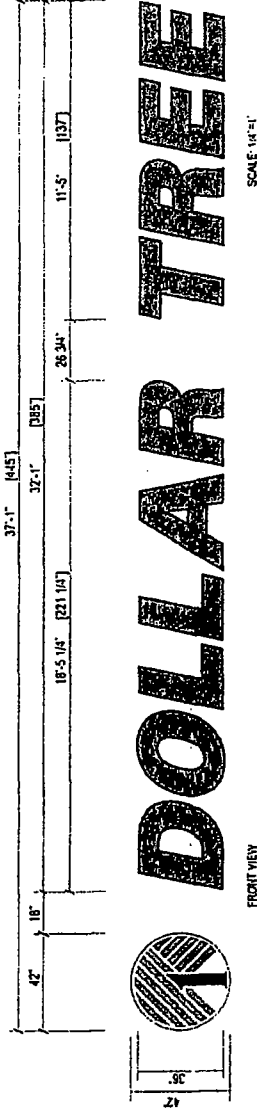

FRONT VIEW

SCALE: 1/4"=1'

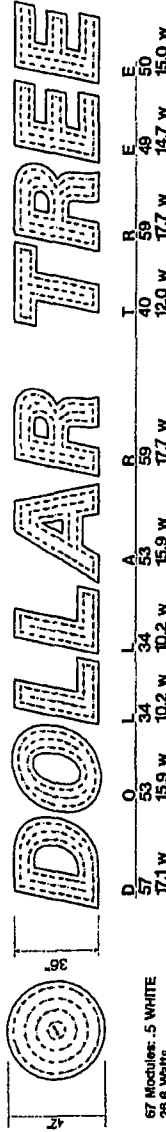

57 Modules: .5 WHITE
 256.6 Watts
 1 Power Supply @ 60w

PROPOSED ELEVATION

SCALE: N.T.S.

- FACES: 7328 WHITE ACRYLIC W/ APPLIED VINYL AS SHOWN
- APPLIED 1ST SURFACE
- RETURNS / TRIM: CP: DURANODIC BRONZE
- ILLUMINATION: GREEN L.E.D. MODULES FOR LETTERS
- ILLUMINATION: WHITE L.E.D. MODULES FOR LOGO
- RACEWAY: SW AESTHETIC WHITE / STD SMOKE PUTTY

- V-2 ALUMINUM EXTRUSION VINYL GREEN
- V-3 3/4" x 3/4" x 1/4" TRIM VINYL
- V-4 3/4" x 3/4" x 1/4" TRIM VINYL
- V-5 3/4" x 3/4" x 1/4" TRIM VINYL
- V-100 3/4" x 3/4" x 1/4" TRIM VINYL

488 Modules: .3 GREEN
 1466.4 Watts
 3 Power Supply @ 60w
 *Layout based on can depth no larger than 6".




ENDING VIEW

SCALE: N.T.S.

JONES SIGN Your Vision Accomplished GREEN BAY · PHILADELPHIA SAN DIEGO · LAS VEGAS www.jonesign.com		JOB # 213543-R3 DATE 2/18/2016 PROJECT PHILADELPHIA DATE 2/18/2016 PROJECT LAS VEGAS		CLIENT / APPROVAL DATE APPROVED DATE		EXTERIOR SIGNAGE 4441 W. Diversey Chicago, IL 60639 DESIGNER: JONES SIGN CONCEPTUAL		SHEET NUMBER 1.0	
--	--	--	--	---	--	---	--	---------------------	--

CL.1 42" LOGO - FLUSH MOUNTED (Qty 1)

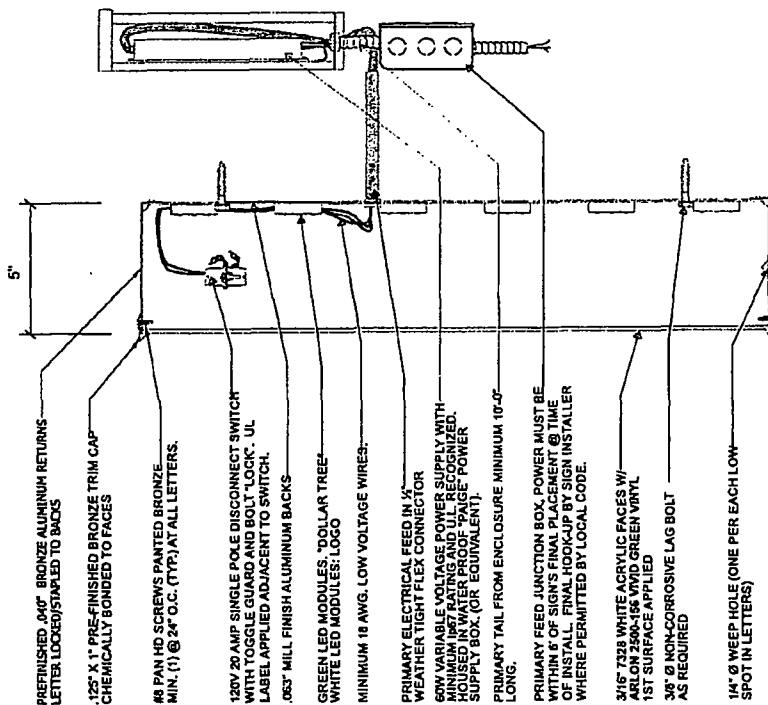

GENERAL NOTES:

- ALL LISTED
- ALL ELECTRICAL WORK SHALL BE PERFORMED BY A LICENSED ELECTRICIAN
- ALL ELECTRICAL WORK SHALL BE IN ACCORDANCE WITH THE NATIONAL ELECTRICAL CODE (NEC) AND ALL MANUFACTURER'S LABEL LOCATIONS NEXT TO DISCONNECT SWITCH
- ALL ELECTRICAL CARRYING METAL PARTS OF SIGN SHALL BE GROUNDED & BONDING IN ACCORDANCE WITH THE NEC
- ALL WIRING CONTAINED IN ENCLOSED AREAS WITHIN LAMP SHALL BE PROTECTED
- ALL ELECTRICAL WORK SHALL BE DONE IN ACCORDANCE WITH THE NATIONAL ELECTRICAL CODE (NEC) AND ALL MANUFACTURER'S LABEL LOCATIONS NEXT TO DISCONNECT SWITCH
- THE SIGN BOX IT SHALL PASS THROUGH LISTED NUMBER OVERSET

UL LABELS REQUIRED

THIS SIGN IS APPROVED BY THE LISTING AGENCY IN ACCORDANCE WITH THE UL STANDARD FOR LISTED ELECTRICAL EQUIPMENT. THE LISTING AGENCY HAS REVIEWED THE SIGN AND FOUND IT TO BE IN ACCORDANCE WITH THE UL STANDARD FOR LISTED ELECTRICAL EQUIPMENT.

 
 
UL LISTED

A listing document is available on the UL website at www.ul.com and at all UL offices. A listing document is also available at all UL offices.

MOUNTING METHOD TABLE

PREFERRED MOUNTING METHOD

3/8" THRU BOLTS



ALTERNATE MOUNTING METHOD

MUST BE APPROVED BY JONES SIGN BEFORE USING

3/8" LAGS W/ EXPANSION SHIELDS (USE ONLY WHEN ACCESS IS NOT AVAILABLE FOR THRU BOLTING)

2" LAG W/ EXPANSION SHIELD

(WHEN ACCESS IS NOT AVAILABLE FOR THRU BOLTING)

CONCRETE

CABINET FRAME

OR RACEWAY BAR

DEPTH OF EMBED:

SIGN 1 - ELECTRICAL DETAILS

(1) 60 W POWER SUPPLIES @ .58 AMPS EACH

TOTAL AMPS: 1.16

(1) 20 AMP 120V CIRCUIT REQUIRED

JONES SIGN Your Vision Accomplished GREEN BAY - PHILADELPHIA SAN DIEGO - LAS VEGAS www.jonesign.com		JOB # 213643-R3 DATE 2.14.2016 BY T. J. JONES CHECKED J. J. JONES APPROVED J. J. JONES	CLIENT APPROVAL DATE LAMP, GND APPROVAL DATE QC APPROVED DATE	EXTERIOR SIGNAGE 4441 W Diversey Chicago, IL 60639 CONCEPTUAL	SHEET NUMBER 1.2
--	--	--	--	--	---------------------


CL.2 14 3/8" FACE LIT CHANNEL LETTERS ON EXISTING SIGN (QTY 2)

SQUARE FOOTAGE: 57.19

ALLOWABLE SQUARE FOOTAGE: 400



DISTANCE FROM SIGN POST TO CURB: 12'

DISTANCE FROM FRONT OF SIGN TO CURB: 8'-2 1/4"

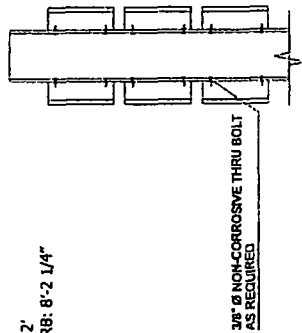


3/8" Ø NON-CORROSIVE THRU BOLT AS REQUIRED

COUNTERSINK SCREWS INTO EXISTING FRAME PAINTED TO MATCH FACE PANEL

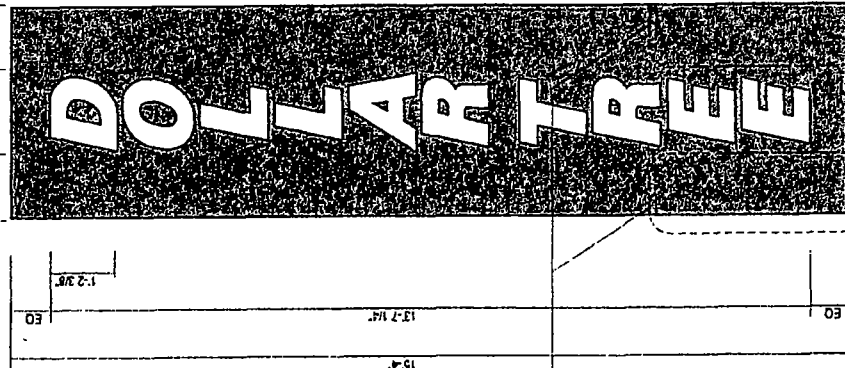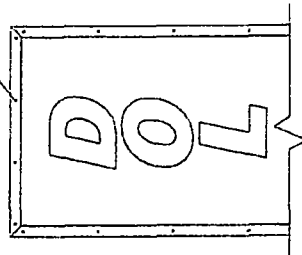

LOCATION OF POWER SUPPLIES

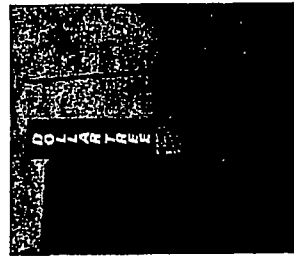


SCALE: N.T.S.

EVENING VIEW


SCALE: 1/2" = 1'

SIDE VIEW

SCALE: 1/2" = 1'

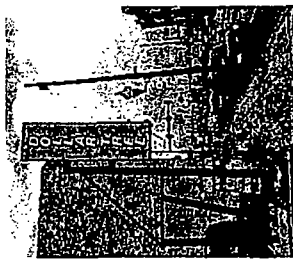

SCALE: N.T.S.

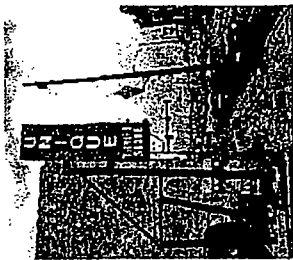

EXISTING ELEVATION

- FACES: T328 WHITE ACRYLIC.
- RETURNS / TRIMCAP: DURANODIC BRONZE
- ILLUMINATION: WHITE L.E.D. MODULES FOR LETTERS
- PAINT EXISTING CABINET GREEN TO MATCH ARLOIN #2500-156 VIVID GREEN.
- NEW .080 ALUMINUM FACE PANELS ON SIGN W/ FINISH TO MATCH ARLOIN #2500-156 VIVID GREEN.

*NOTE: LETTERS PRE MOUNTED TO ALUMINUM FACE PANEL PRIOR TO INSTALLATION IN FIELD.

JONES SIGN Your Vision Accomplished GREEN BAY • PHILADELPHIA SAN DIEGO • LAS VEGAS www.jonesign.com		J051 213643-R3 DATE: 2.16.2016 DESIGNED BY: JAI DRAWN BY: JAI CHECKED BY: JAI	CLIENT APPROVAL UNLESS APPROVAL DATE:	DATE:	EXTERIOR SIGNAGE 4441 W. Diversey Chicago, IL 60635 DESIGN PHASE: CONCEPTUAL	SHEET NUMBER 2.0
--	--	---	---	-------	---	---------------------