



City of Chicago



Or2020-151

Office of the City Clerk

Document Tracking Sheet

Meeting Date:	5/19/2020
Sponsor(s):	Hopkins (2)
Type:	Order
Title:	Issuance of permits for sign(s)/signboard(s) at 225 E Chicago Ave - south elevation
Committee(s) Assignment:	Committee on Zoning, Landmarks and Building Standards

CITY COUNCIL
COMMITTEE ON ZONING, LANDMARKS AND BUILDING STANDARDS

COUNCIL ORDER

RE: Approval of sign over 100 square feet in area or over 24 feet above grade

ORDERED, that the City Council hereby approves the following sign application submitted by:

Applicant*: Ann & Robert H. Lurie Children's Hospital of Chicago

(* The Applicant is the owner of the real property or the business tenant of the real property. Do not list the sign contractor, sign erector, sign company or advertising entity in the above space.)

This Order approves the following sign in accordance with Municipal Code of Chicago Section 13-20-680:

Address of Sign: 225 E Chicago Ave Chicago, IL 60611

Zoning District: DX-12

DOB Sign Permit Application #: 100869516

Sign Details:

1. On-premise X OR Off-premise _____

2. Static sign X OR Dynamic-image display sign _____

3. Number of sign faces 1

4. Projecting over the public way No (Yes or No) If yes, Public Way Use #: _____

5. Dimensions: Length 34 feet 3 inches Height 5 feet 4 inches

Total square feet in area: 183

6. Height above grade: 24 feet 4 inches *To top of sign or sign structure*


7. Elevation (side of building or lot where the sign will be erected): South Elevation (E Superior St)

8. Name of Sign Contractor/Erector: South Water Signs

To be legal, such sign shall comply with all provisions of Title 17 of the Chicago Municipal Code ("Zoning Ordinance") and all other provisions of the Municipal Code governing the permitting, construction and maintenance and removal of signs and sign structures. Failure of the applicant and the applicant's successors to comply shall be grounds for invalidation or revocation of the sign permit.

Brian Hopkins
Alderman

02
Ward

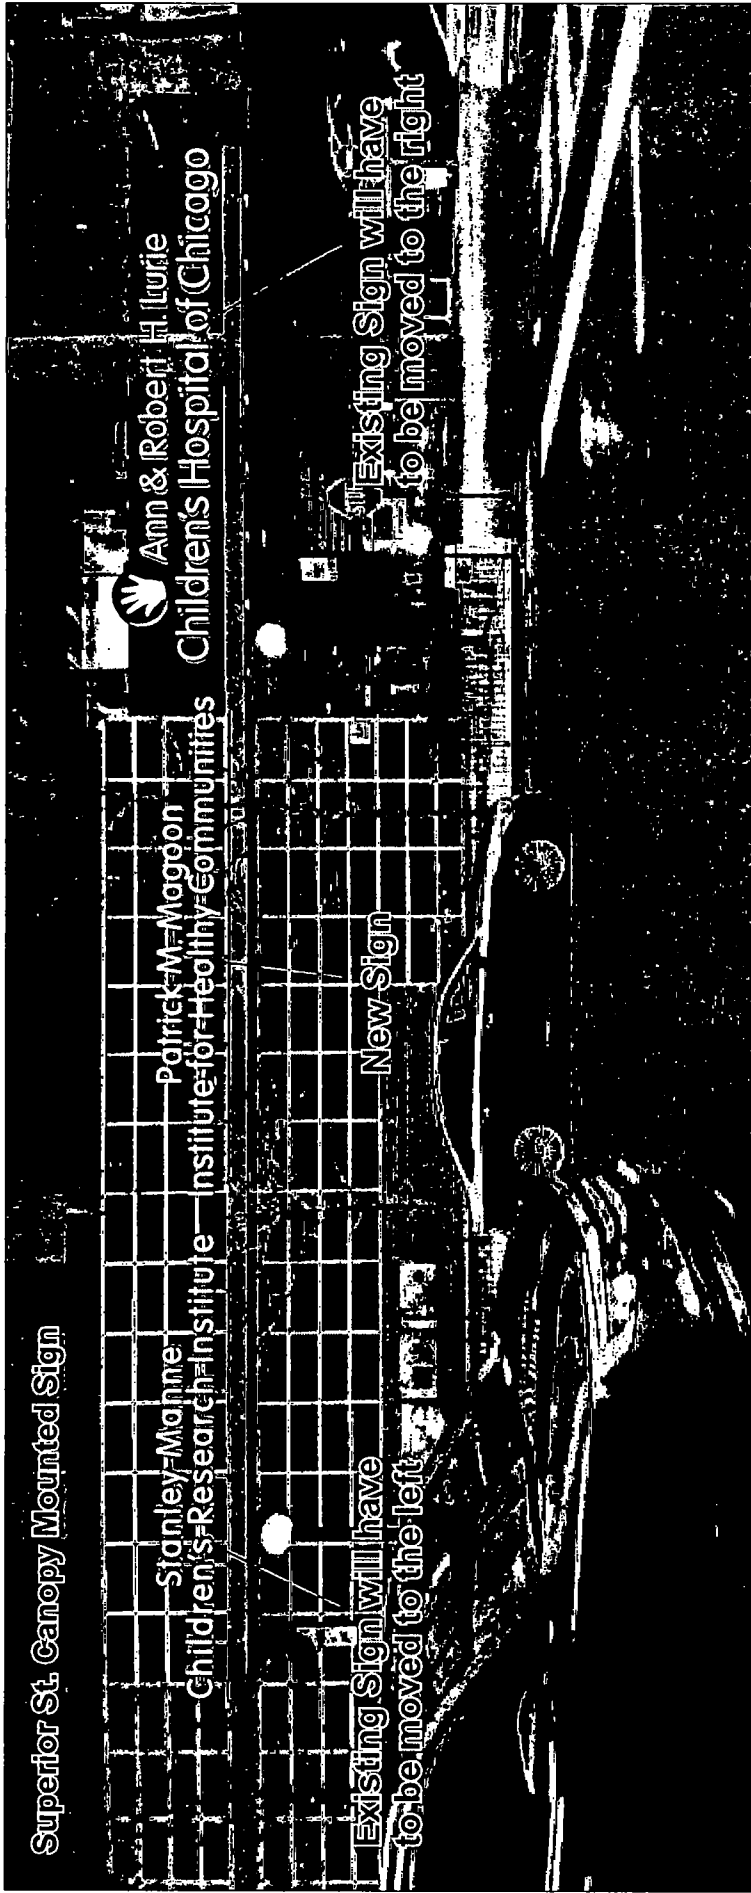

Approximate renderings not to scale.



Client
Ann & Robert Lurie Children's Hospital
Patrick Magoon Institute for Healthy Communities

Project Name & Location
Chicago Ave
Chicago, IL


Date
11.13.19

Drawn By
SW

THIS DRAWING IS PROPERTY
OF SOUTH WATER SIGNS
ALL RIGHTS OF REPRODUCTION
ARE RESERVED BY
SOUTH WATER SIGNS



LISTED

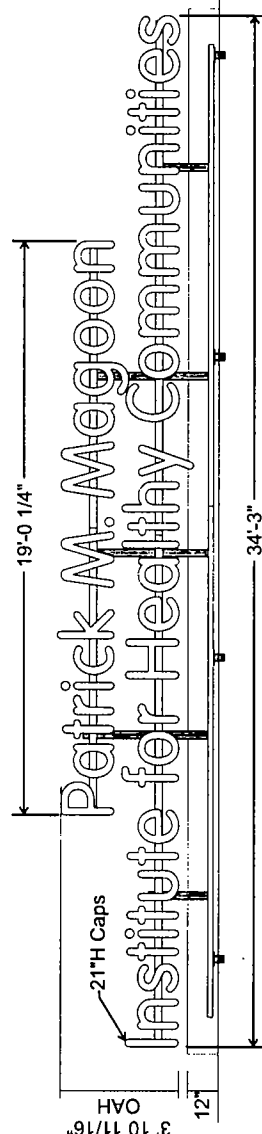

133.29 Sq. Ft.

Scale: 1/4" = 1'-0"

Fabricated 8" Deep Stainless Steel letters internally illuminated with white LED lighting #4 Horizontal Brushed returns - *See LED notes for matching existing conditions

1/2" Clear polycarbonate reverse-push (Trimless) through routed faces with second surface white Diffuser (3M 3635-70) & First surface White Vinyl (3M 230-20) for even lighting

Letters mounted to common 3" x 3" common aluminum support rails with additional vertical 1" x 1" square tube supports - Painted to match Building (P10 Medium Gray)

*Paint match sample required for Medium Gray - *See following layouts for vertical 1" x 1" supports

Fabricated 12"H x 32" 6"W aluminum clam-shell shroud to hide all mounting, installed after sign and anchored directly with tek screws into canopy. Painted to match building (P10 Medium Gray)


Supports & rail sections mounted to existing steel canopy with sandwiched steel plates

*Additional canopy information/survey req. *

Qty 2 Sets of letters

*All materials and finishes to match existing letters

Superior & Chicago Ave - Canopy Mounted ID Signs

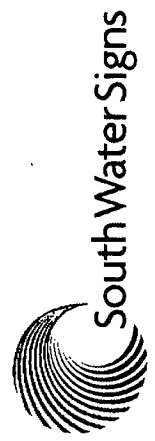

Client: Ann & Robert Lurie Children's Hospital
Patrick Magee Institute for Healthy Communities

Customer Approval: _____

Project Name & Location: Chicago Ave
Chicago, IL

App. Number: 7037945

Date: 11.13.19

SWs W/O CODE: F ☒ E ☒ R ☒
V ☒ C ☒ O ☒
P ☒

Drawn By: SW

By: Zuppa

T 14.19 \$/W
1 25.15 \$/W
22.17.28 \$/W
65.06.26 \$/W

TRIMCAP-LESS FACE-LIT CHANNEL LETTERS
LED ILLUMINATION - RACEWAY MOUNT

- 1 ALUMINUM RETURNS/BACKS
- 2 3/4" SQUARE TUBE SUPPORT
- 3 LED ILLUMINATION (AQUILIGHT / SLOAN)
- 4 ELECTRICAL PASS-THRU
- 5 RETAINING SCREW
- 6 OSRAM POWER SUPPLIES / GENERAL LED / ADVANCE
- 7 DISCONNECT/TOGGLE SWITCH
- 8 1/2" ALUMINUM RAIL
- 9 SS SUPPORT FRAME/WIREWAY

General Notes:
1. All wiring shall be in accordance with the National Electrical Code (NEC) and all wiring shall be grounded.
2. All wiring shall be in accordance with the NEC code book.
3. All wiring shall be in accordance with the NEC code book.
4. All wiring shall be in accordance with the NEC code book.

General Notes:
1. All wiring shall be in accordance with the National Electrical Code (NEC) and all wiring shall be grounded.
2. All wiring shall be in accordance with the NEC code book.
3. All wiring shall be in accordance with the NEC code book.
4. All wiring shall be in accordance with the NEC code book.

General Notes:
1. All wiring shall be in accordance with the National Electrical Code (NEC) and all wiring shall be grounded.
2. All wiring shall be in accordance with the NEC code book.
3. All wiring shall be in accordance with the NEC code book.
4. All wiring shall be in accordance with the NEC code book.

General Notes:
1. All wiring shall be in accordance with the National Electrical Code (NEC) and all wiring shall be grounded.
2. All wiring shall be in accordance with the NEC code book.
3. All wiring shall be in accordance with the NEC code book.
4. All wiring shall be in accordance with the NEC code book.

MOUNTING HARDWARE

Lag Screw
☐ Wood & Masonry Applications

Toggle Bolt
☐ Hollow Walls

Wedge Anchor
☐ Masonry Applications

Sleeve Anchor
☐ Masonry Applications

Thru-Bolt w/ U-Channel
☐ Hollow Walls w/ Rear-Access

THIS DRAWING IS PROPERTY OF SOUTH WATER SIGNS. ALL RIGHTS OF REPRODUCTION ARE RESERVED BY SOUTH WATER SIGNS.

1-844-344-3444

LISTED